


# College Medical Center Hawthorne Campus

## Facility No. 11845

05/07/18

BLD-02914 - Original Building - Bldg 01

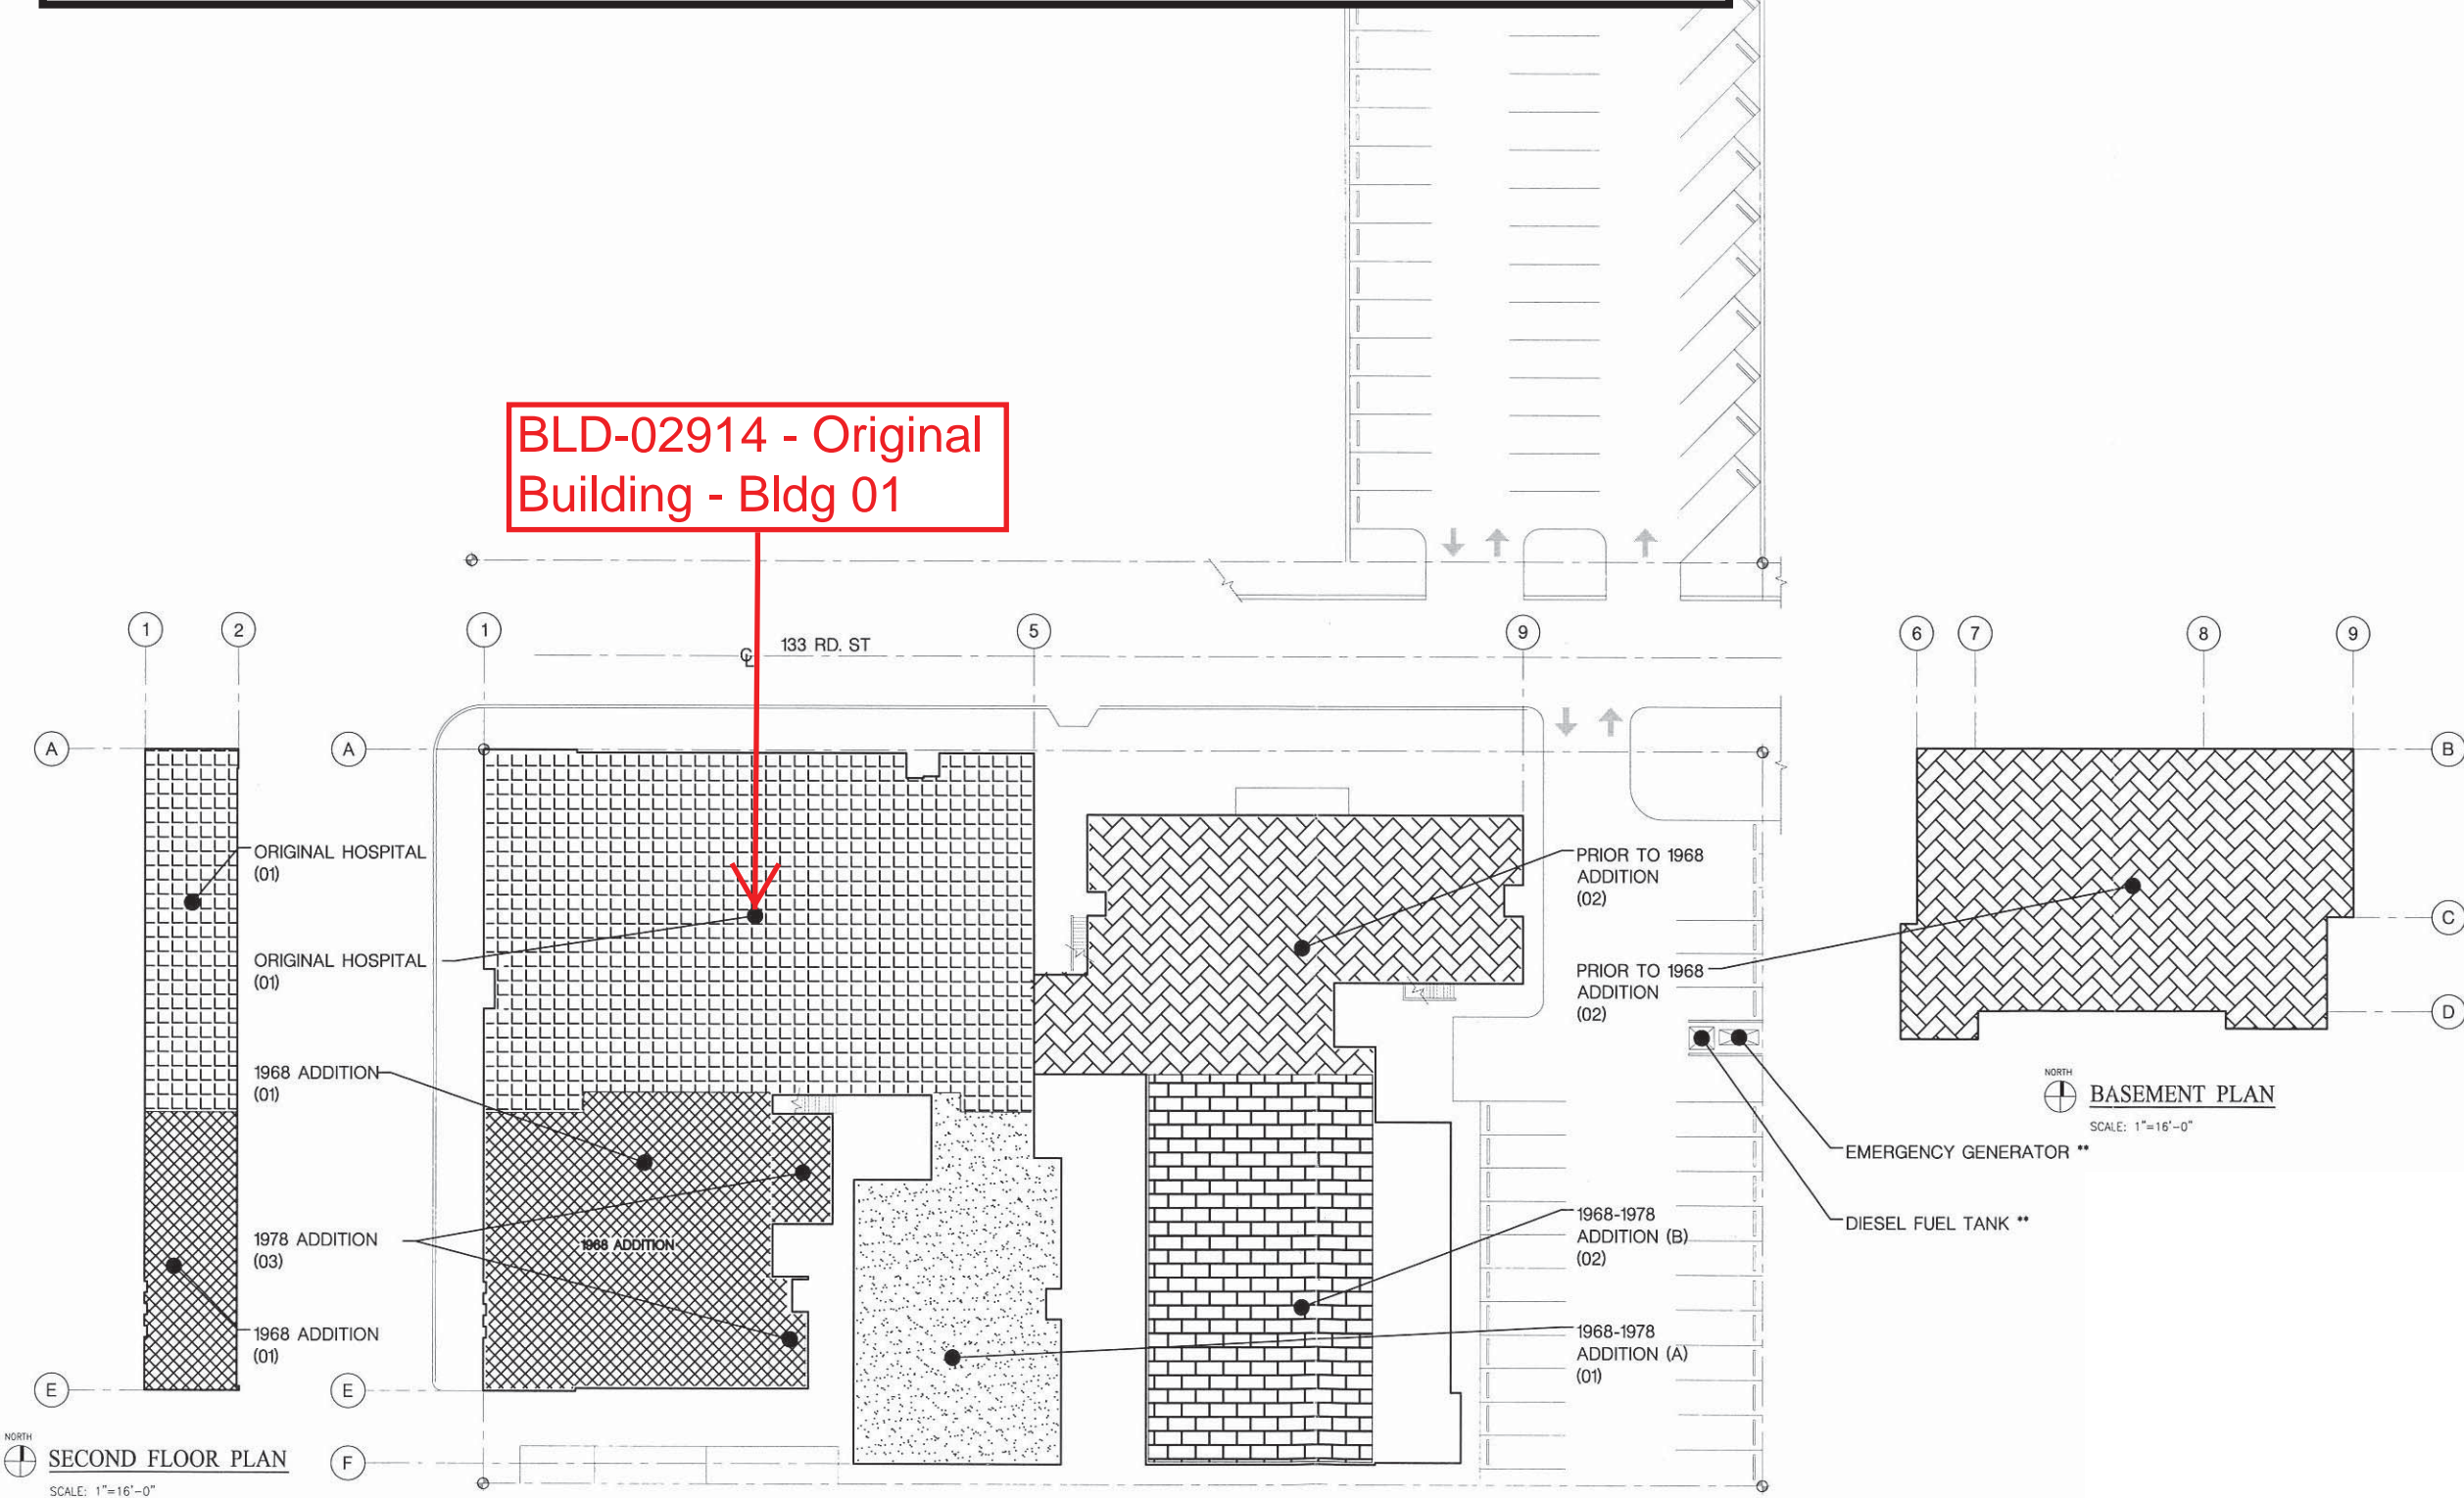

NORTH  
SECOND FLOOR PLAN  
SCALE: 1"=16'-0"

NORTH  
FLOOR PLAN  
SCALE: 1"=16'-0"

NORTH  
BASEMENT PLAN  
SCALE: 1"=16'-0"