

 


# Usc Kenneth Norris Jr. Cancer Hospital Facility No. 15179

4/22/2024

For Enlarged Plan  
See Page 2

BLD-03689 -  
Topping Tower -  
Bldg 02


BLD-00317 - Cancer  
Research Institute (Ezralow  
Tower) - Bldg 01

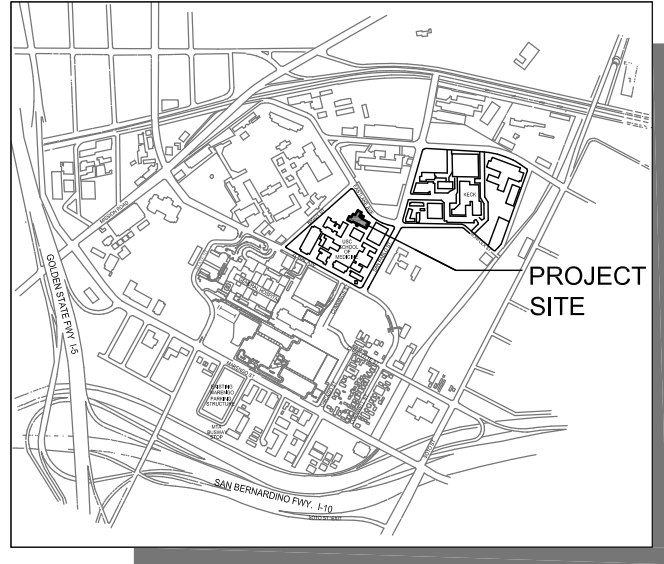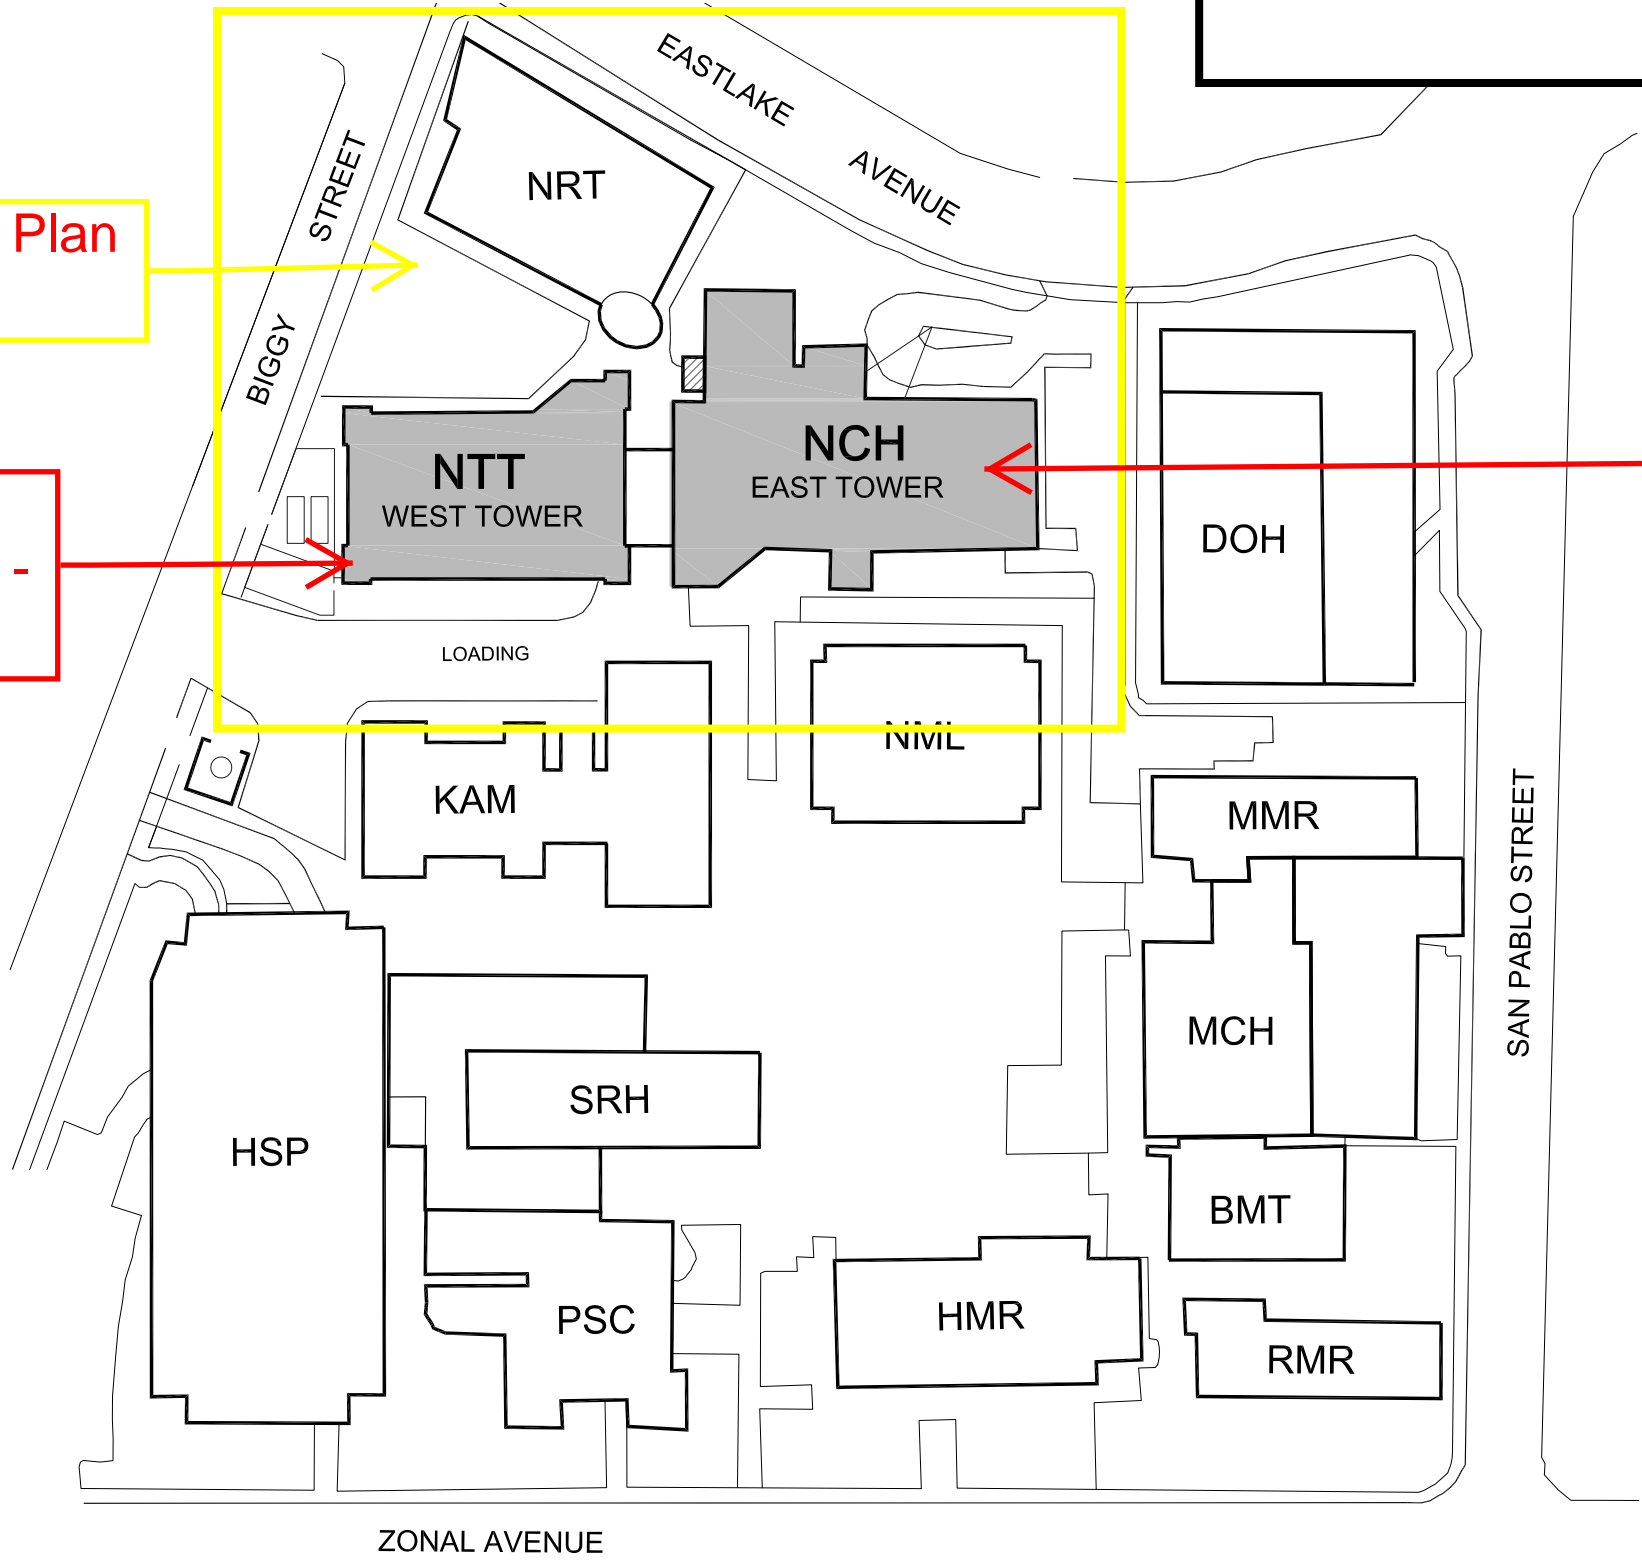

**SITE PLAN**  
SHOWN FOR REFERENCE

SCALE: NTS



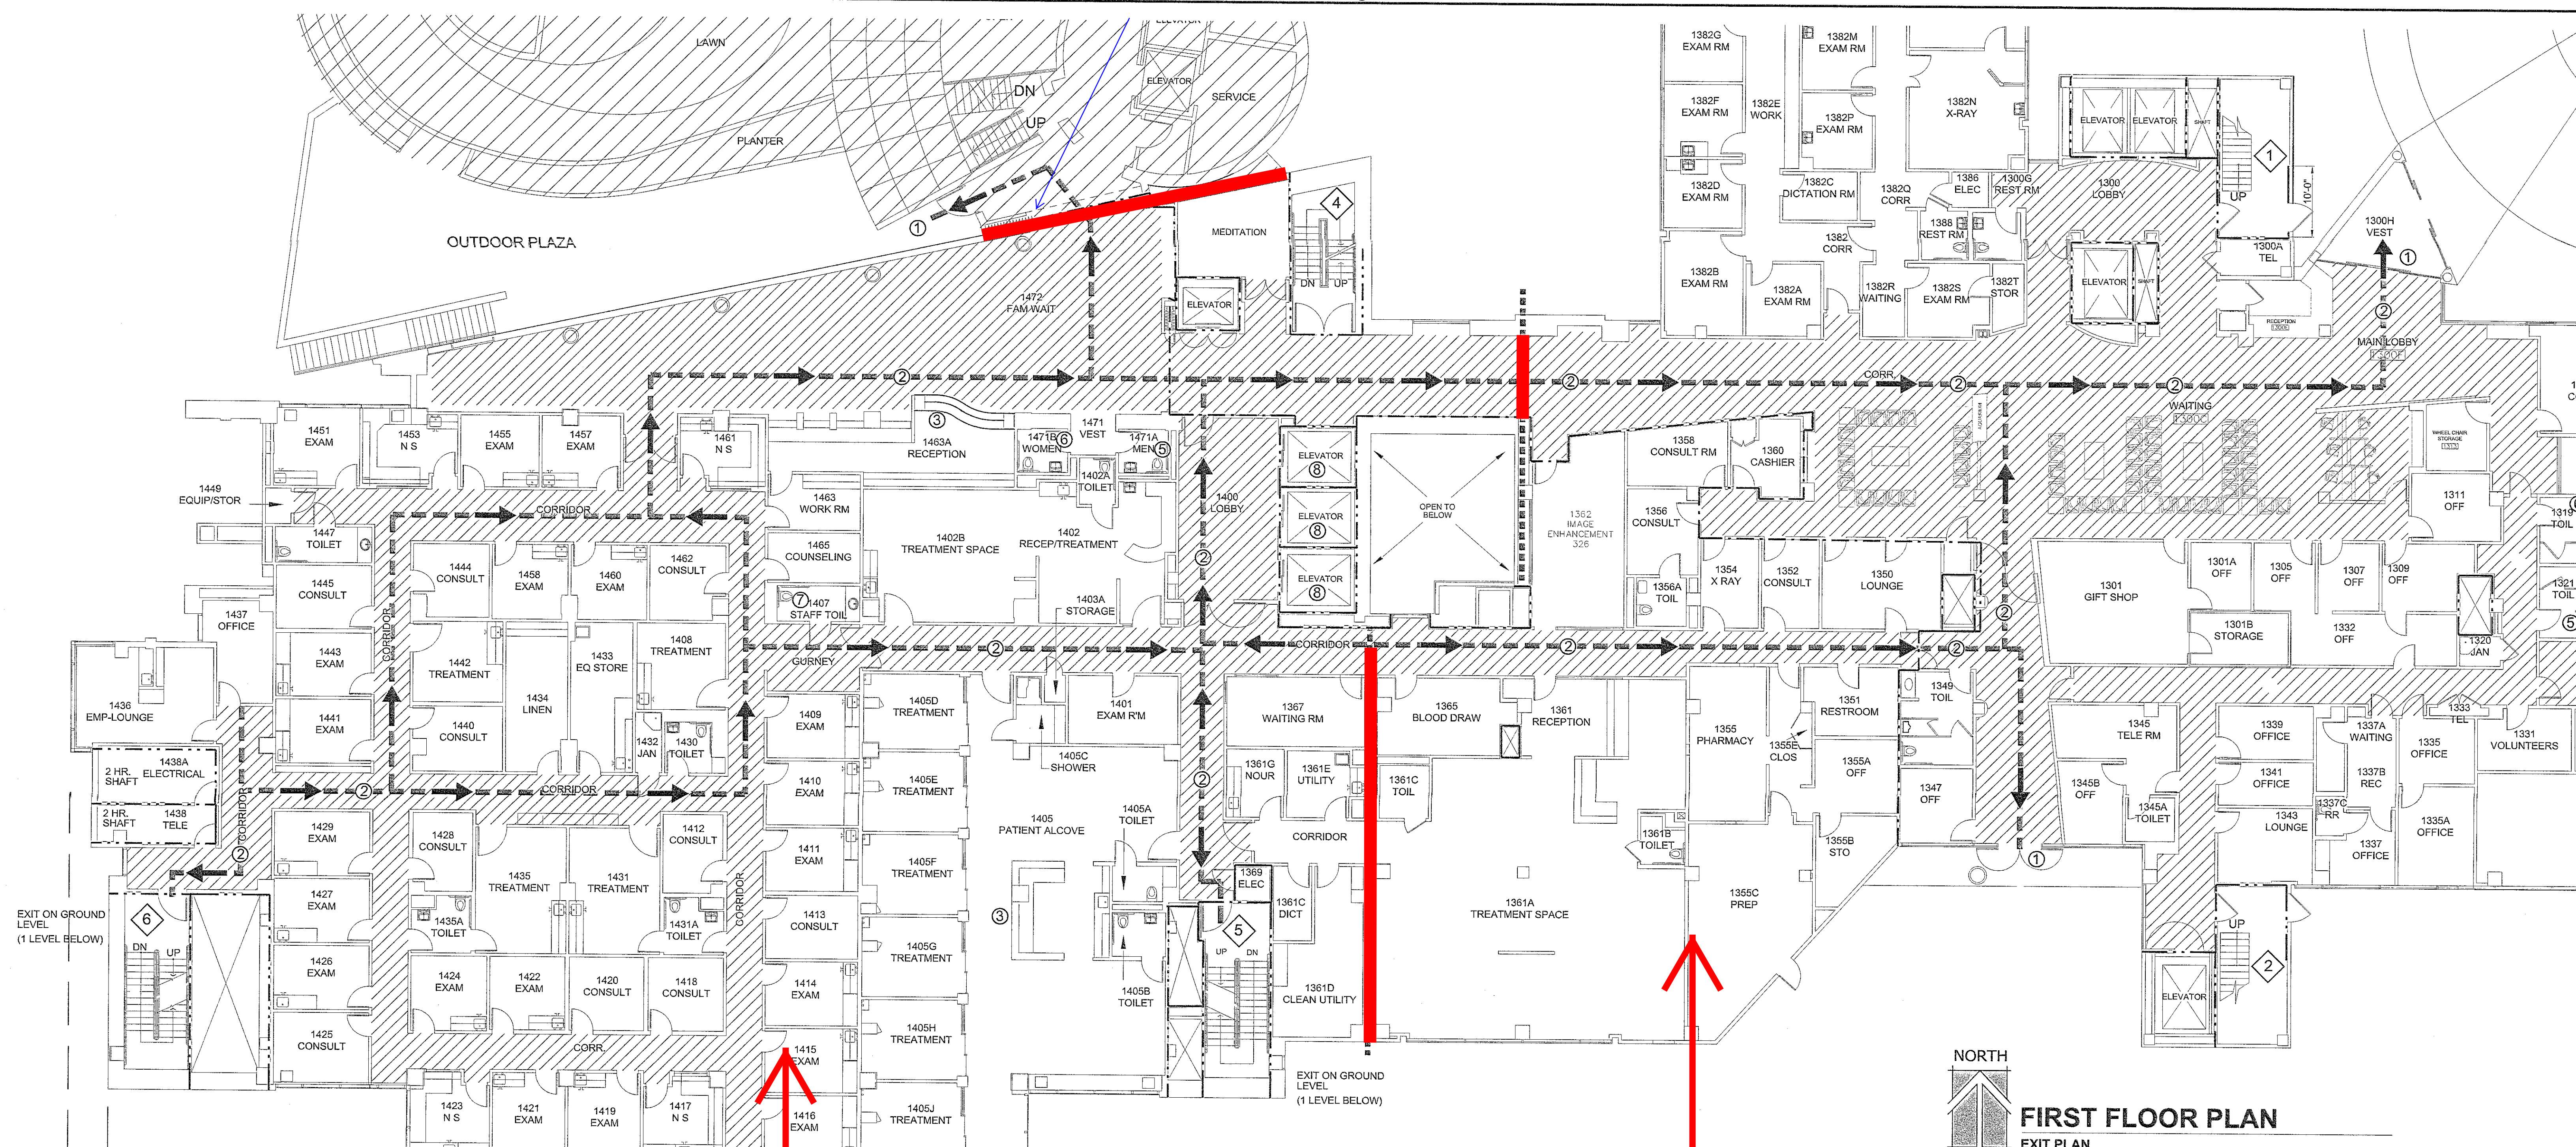

BLD-03689 - Topping Tower - Bldg 02

BLD-00317 - Cancer Research Institute (Ezralow Tower) - Bldg 01

# Usc Kenneth Norris Jr. Cancer Hospital Facility No. 15179