

**BLD-05596 - Central Plant
- Bldg 02
OSHPD 1 - SPC 5 NPC 4**

**BLD-05801 - North
Canopy - Bldg 04
OSHPD 1 - SPC 5 NPC 4**


**BLD-05800 - Loading
Dock Canopy - Bldg 03
OSHPD 1 - SPC 5 NPC 4**

**BLD-05595 - Main
Hospital Facility - Bldg 01
OSHPD 1 - SPC 5 NPC 4**

**BLD-05803 - Emergency
Department Canopy -
Bldg 06
OSHPD 1 - SPC 5 NPC 4**

**BLD-05804 - Entrance
Canopy - Bldg 07
OSHPD 1 - SPC 5 NPC 4**


**BLD-05802 - East Canopy
- Bldg 05
OSHPD 1 - SPC 5 NPC 4**

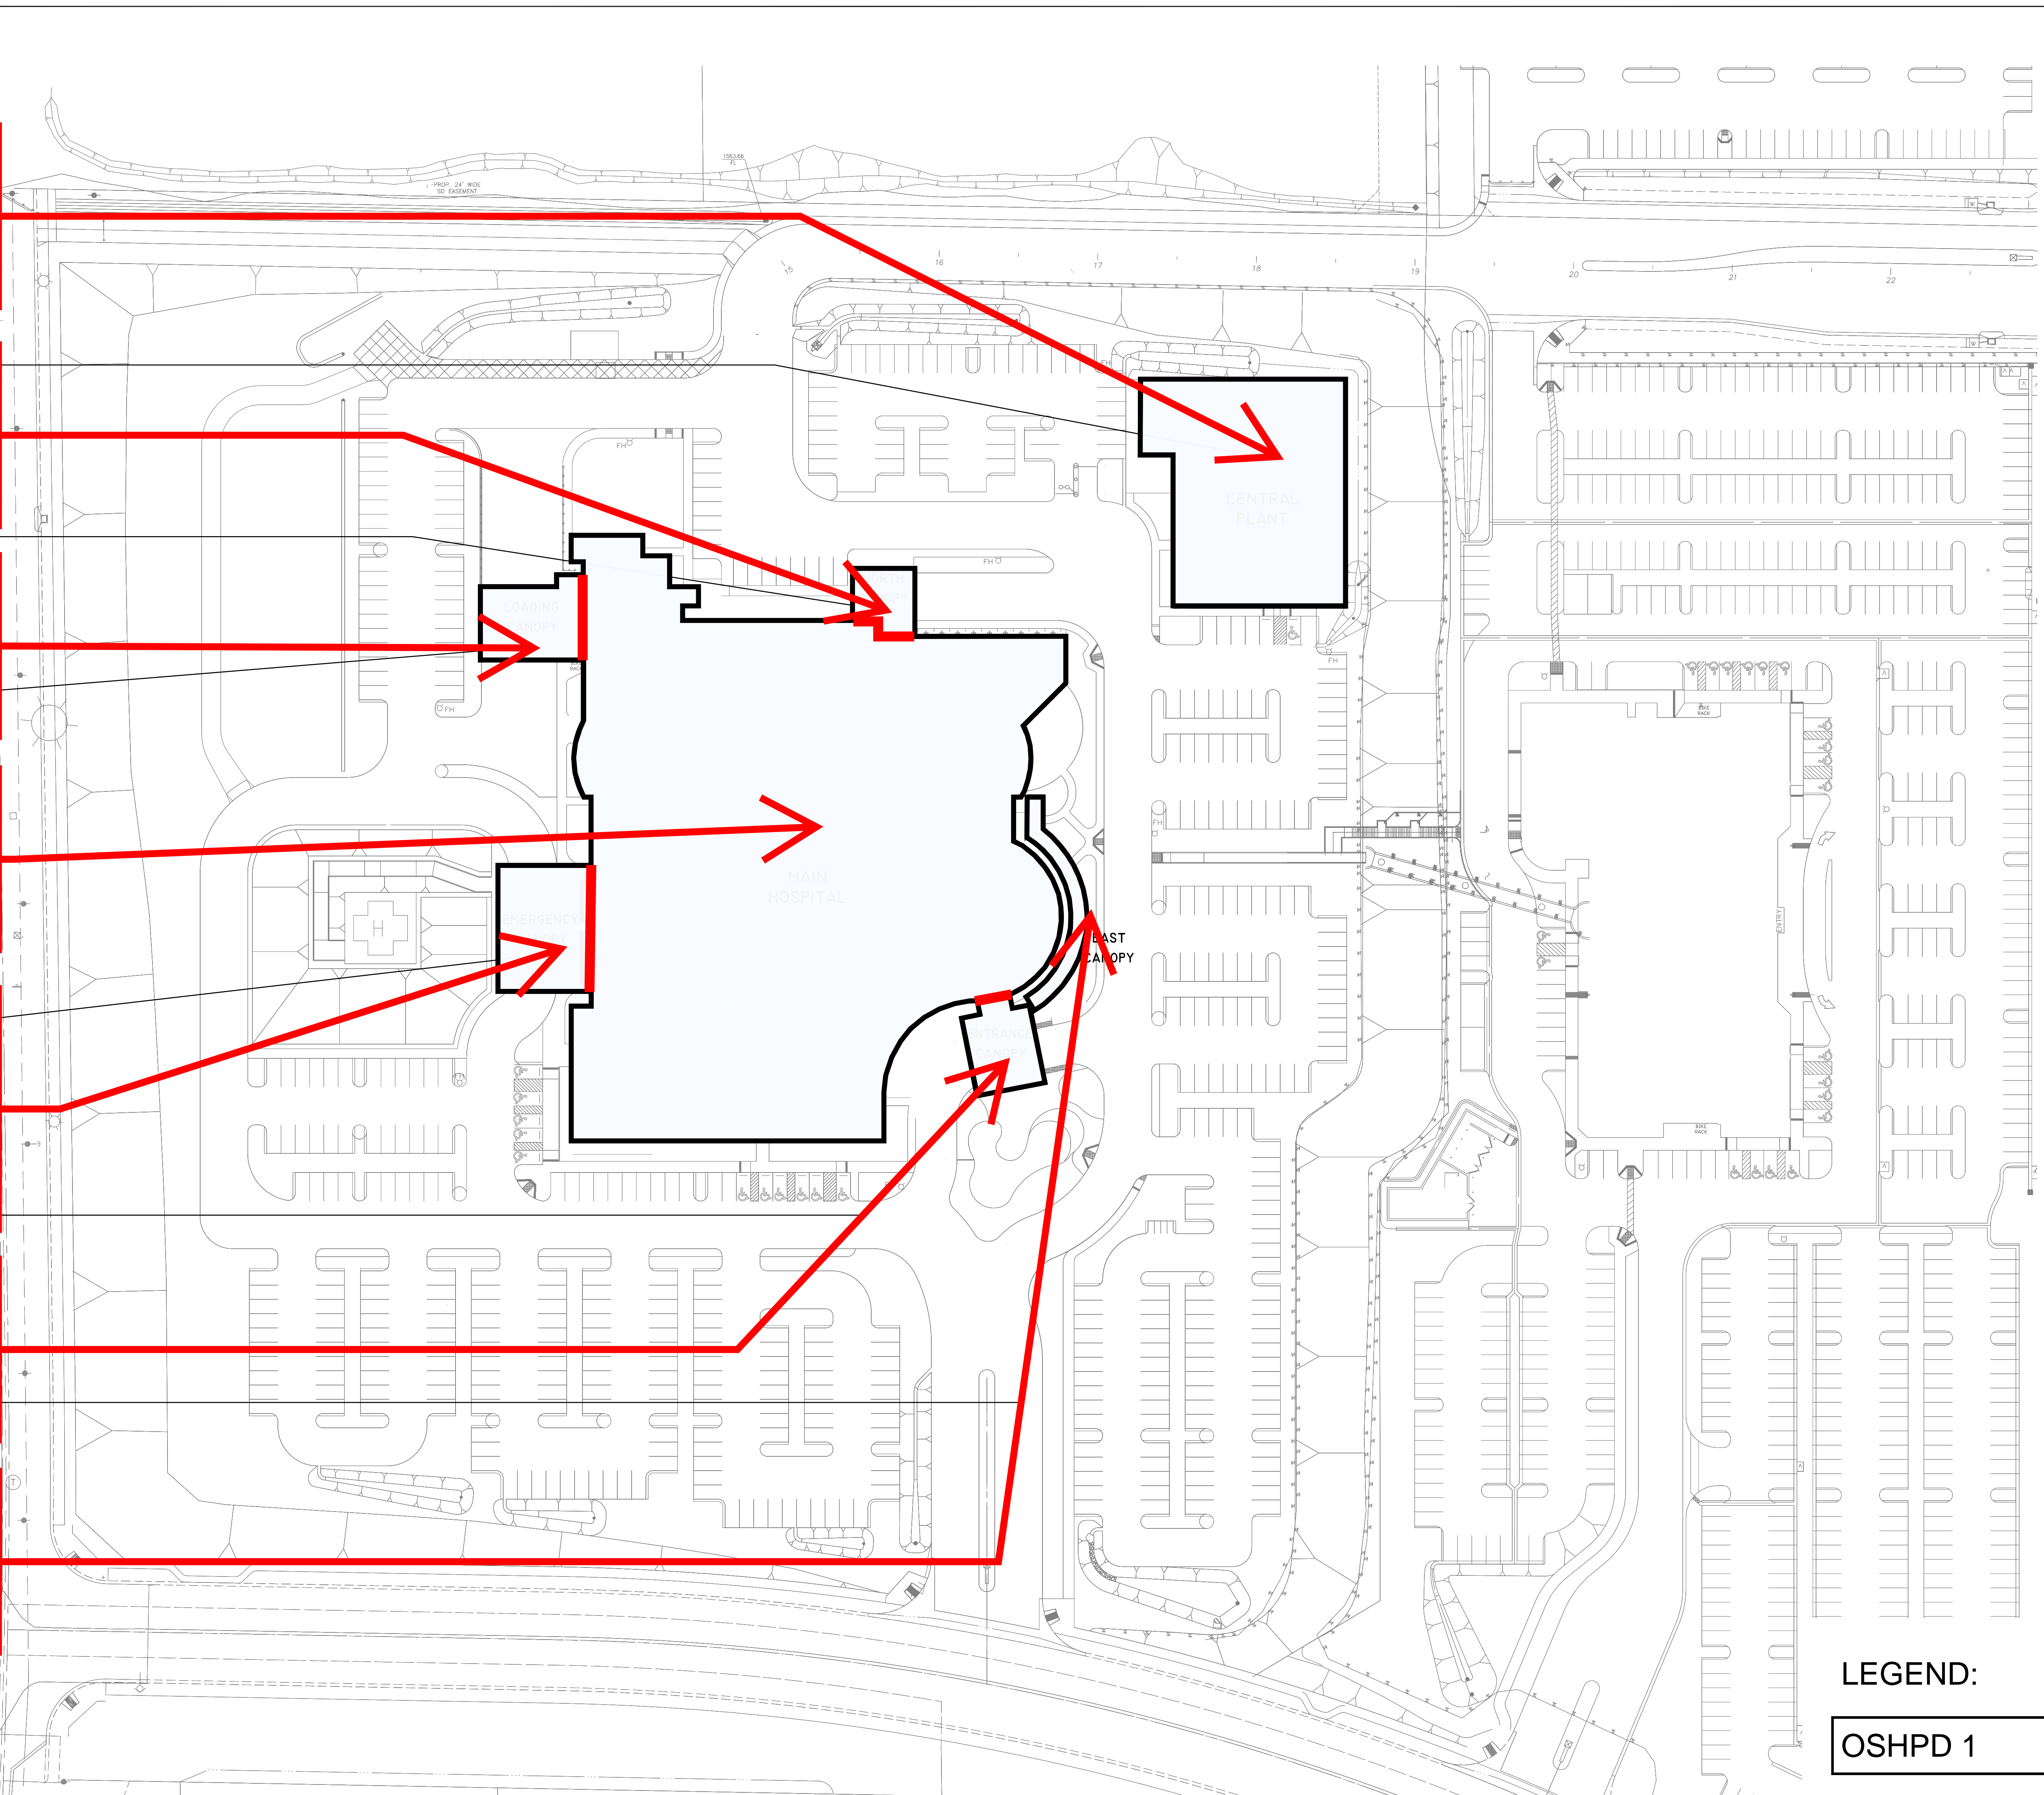


LEGEND:
OSHPD 1
Seismic Separation

Loma Linda University Medical Center - Murrieta Facility No. 18175

3/23/2026

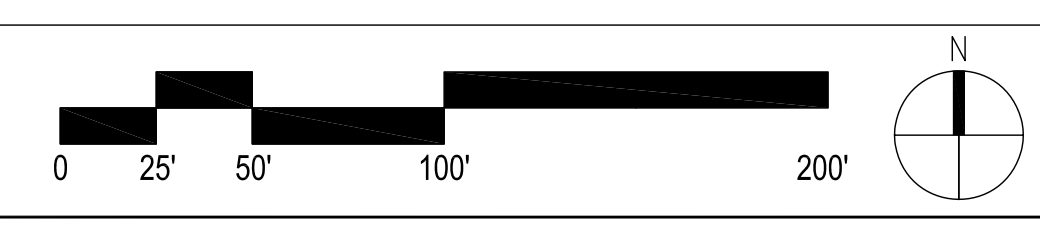

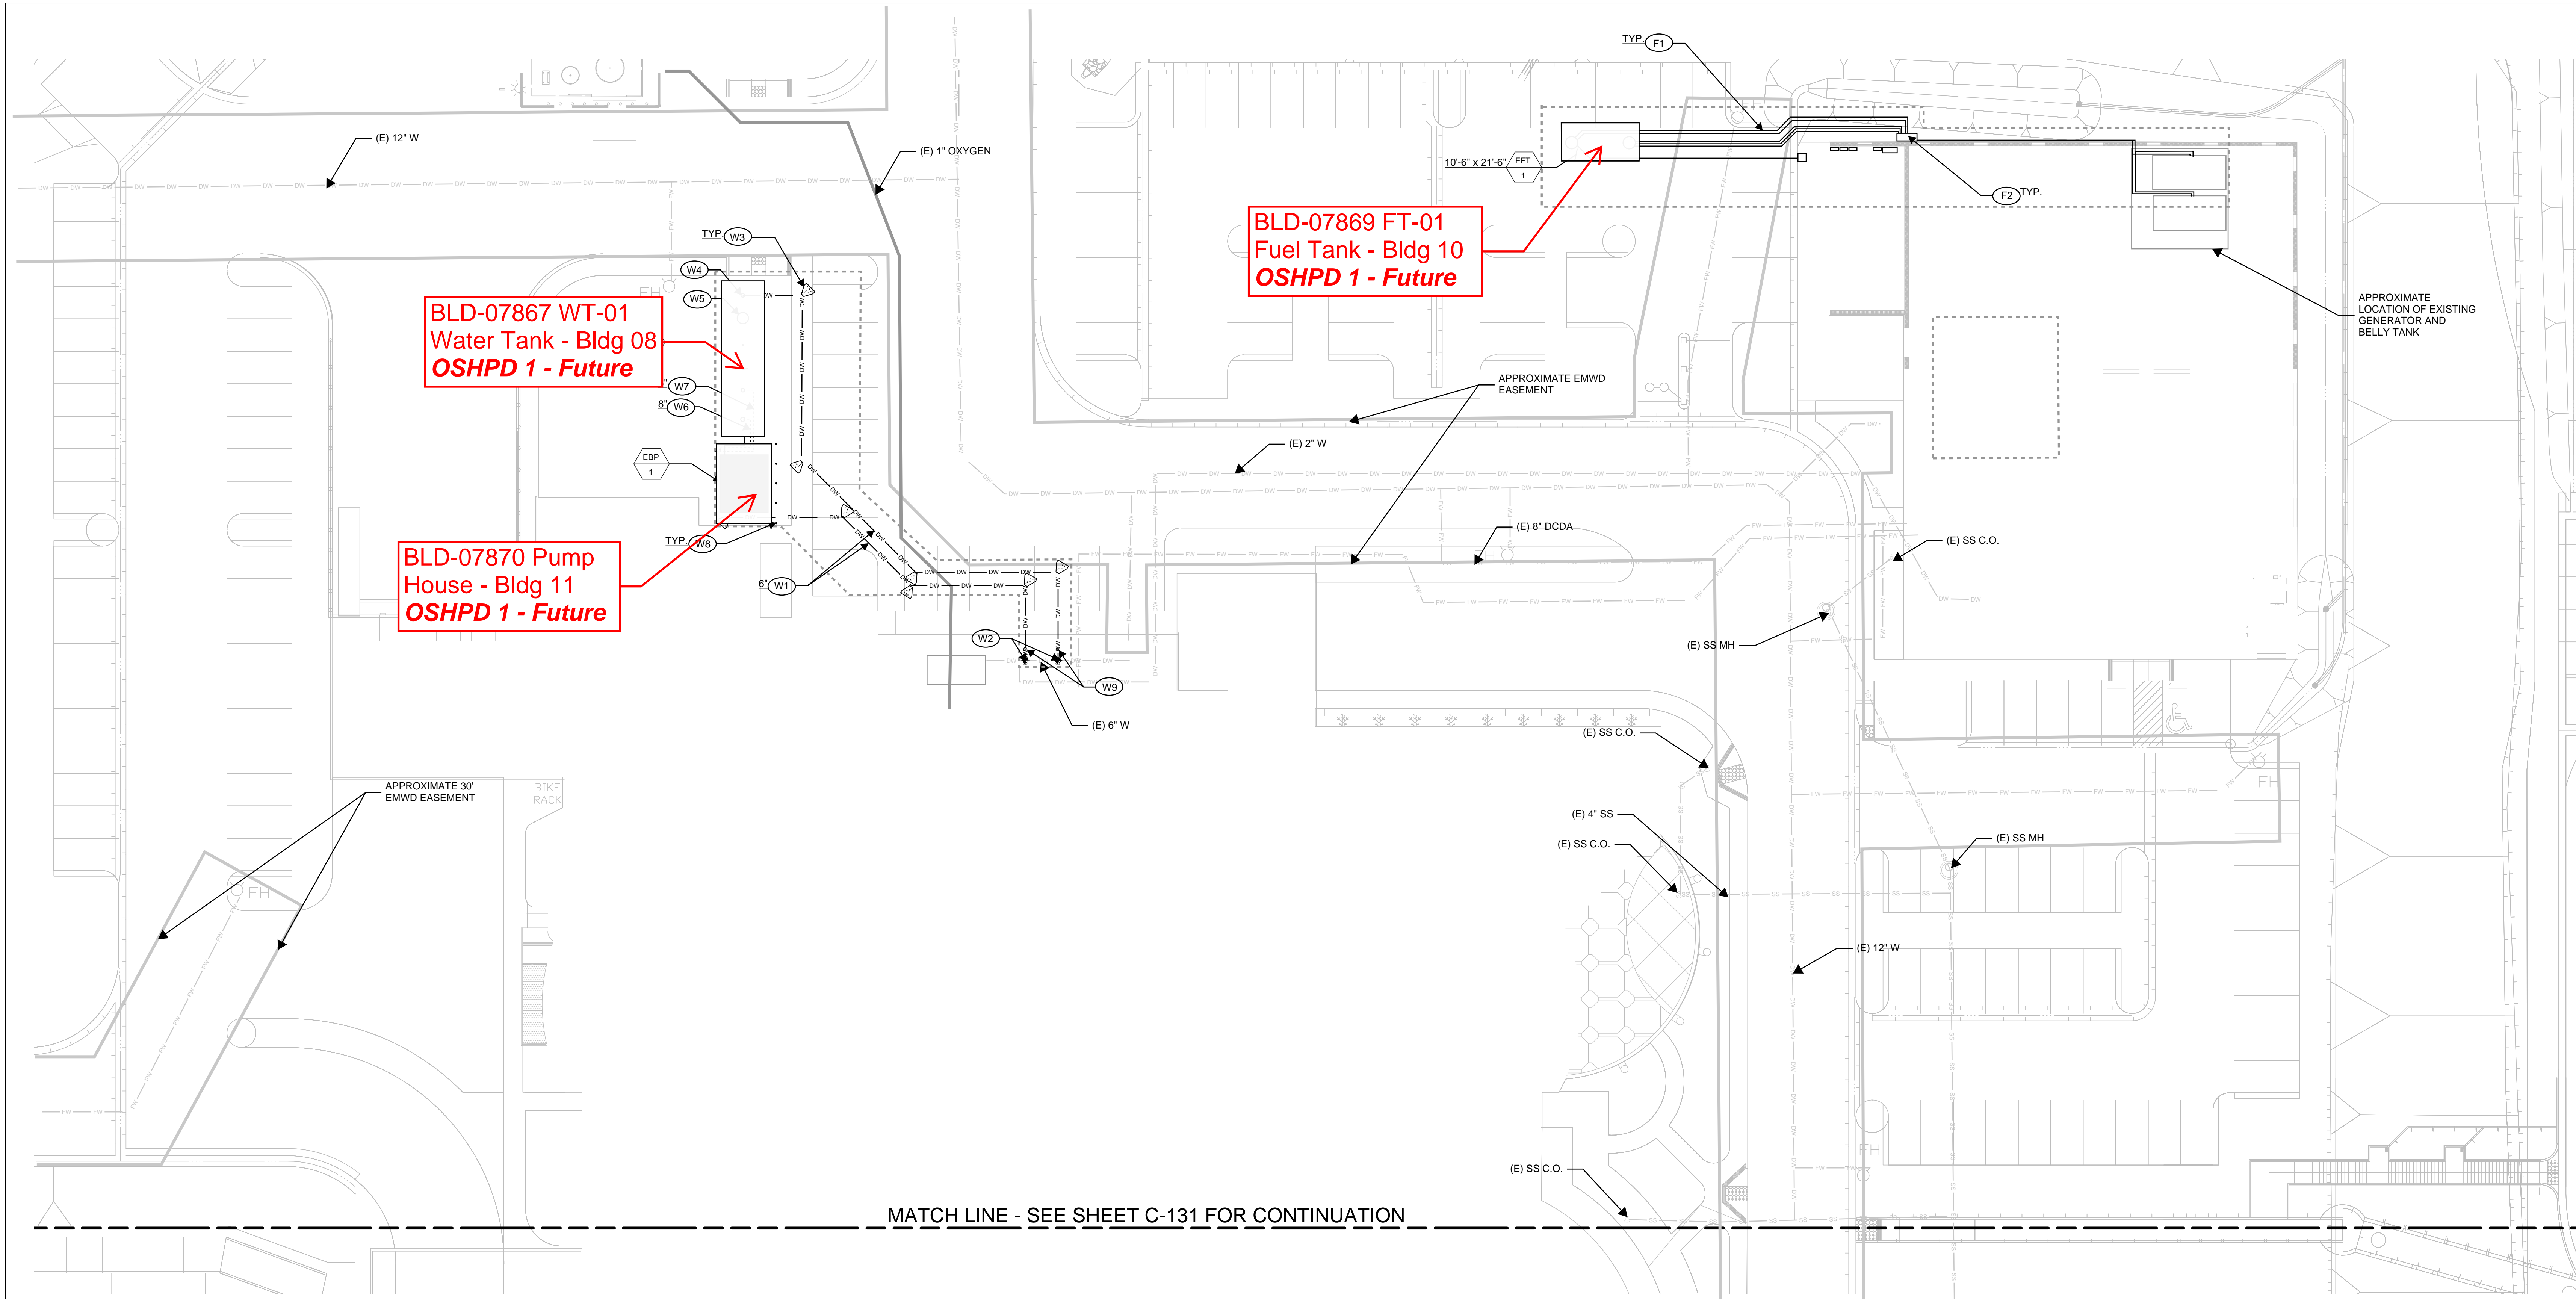

LEGEND:

	LIMIT LINE OF EROSION CONTROL
	PROPERTY LINE (FOR REFERENCE ONLY)
	SAWCUT
	SANITARY SEWER
	DOMESTIC WATER
	EXISTING CONTOURS
	SANITARY SEWER TANK, XERXES OR APPROVED EQUIVALENT, BACKFILL AND DEADMAN PER MANUFACTURER RECOMMENDATIONS. SEE PLUMBING SCHEDULE FOR DETAILS AND SPECIFICATIONS.
	DOMESTIC WATER TANK, XERXES OR APPROVED EQUIVALENT, BACKFILL AND DEADMAN PER MANUFACTURER RECOMMENDATIONS. SEE PLUMBING SCHEDULE FOR DETAILS AND SPECIFICATIONS.
	FUEL TANK, XERXES OR APPROVED EQUIVALENT, BACKFILL AND DEADMAN PER MANUFACTURER RECOMMENDATIONS. SEE PLUMBING SCHEDULE FOR DETAILS AND SPECIFICATIONS.
	PUMP HOUSE, SYNCROFLO OR APPROVED EQUIVALENT. SEE PLUMBING SCHEDULE FOR DETAILS AND SPECIFICATIONS.

UTILITY CONSTRUCTION NOTES:

DOMESTIC WATER

- (W1) DOMESTIC WATER PIPE PER DETAIL 1, SHEET C-500. SIZE PER PLAN. PIPING MATERIAL PER PLUMBING PLAN.
- (W2) DOMESTIC WATER POINT OF CONNECTION TO EXISTING WATER SYSTEM. VERIFY IN FIELD EXACT LOCATION AND DEPTH.
- (W3) THRUST BLOCK PER DETAIL 3, SHEET C-500. PROVIDE RESTRAINED JOINTS WHEN THRUST BLOCK IS NOT FEASIBLE DUE TO SITE CONSTRAINTS.
- (W4) WATER PIPE POINT OF CONNECTION TO DOMESTIC WATER TANK. SEE PLUMBING DRAWINGS FOR CONTINUATION.
- (W5) 30" TRAFFIC TRATED MANWAY COVER FOR WATER TANK. REFER TO PLUMBING SCHEDULE FOR DETAILS AND SPECIFICATIONS.
- (W6) OVERFLOW PIPING. REFER TO PLUMBING PLANS FOR SIZE AND MATERIAL.
- (W7) VENT PIPING. REFER TO PLUMBING PLANS FOR SIZE AND MATERIAL.
- (W8) BOLLARD PER DETAIL 11, SHEET C-500.
- (W9) WATER VALVE AND VALVE BOX PER DETAIL 12, SHEET C-500.

OTHER UTILITIES


- (F1) FUEL LINE SHOWN FOR COORDINATION PURPOSES ONLY. SEE PLUMBING PLANS FOR DETAILS.
- (F2) FUEL TANK EQUIPMENT SHOWN FOR COORDINATION PURPOSES ONLY. SEE PLUMBING PLANS FOR DETAILS.
- (F3) ELECTRICAL LINE SHOWN FOR COORDINATION PURPOSES ONLY. SEE ELECTRICAL PLANS FOR DETAILS.

NOTE:
SEE PLUMBING DRAWINGS FOR PIPING CONFIGURATION, VALVE DETAILS, AND SIZING INFORMATION.

NOTE:
PRIOR TO THE INSTALLATION OF ALL STORM DRAIN AND SEWER MAIN LINE CONNECTIONS, THE CONTRACTOR SHALL POTHOLE AND VERIFY THE HORIZONTAL AND VERTICAL LOCATION OF THE MAIN LINE. IF CONDITIONS DIFFER FROM THOSE ON THE PLAN, THE CONTRACTOR SHALL NOTIFY THE ENGINEER AND SHALL NOT BEGIN CONSTRUCTION UNTIL THE CHANGED CONDITION HAS BEEN EVALUATED.


LEGEND:

	OSHPD 1
	Seismic Separation

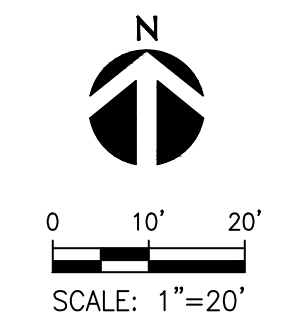

TITLE	UTILITY PLAN
PROJECT NO.	2023014.20
DRAWN: SG	CHECK: BK
ISSUE: HCAI SUBMITTAL	DATE: FEBRUARY 25, 2026

MATCH LINE - SEE SHEET C-130 FOR CONTINUATION

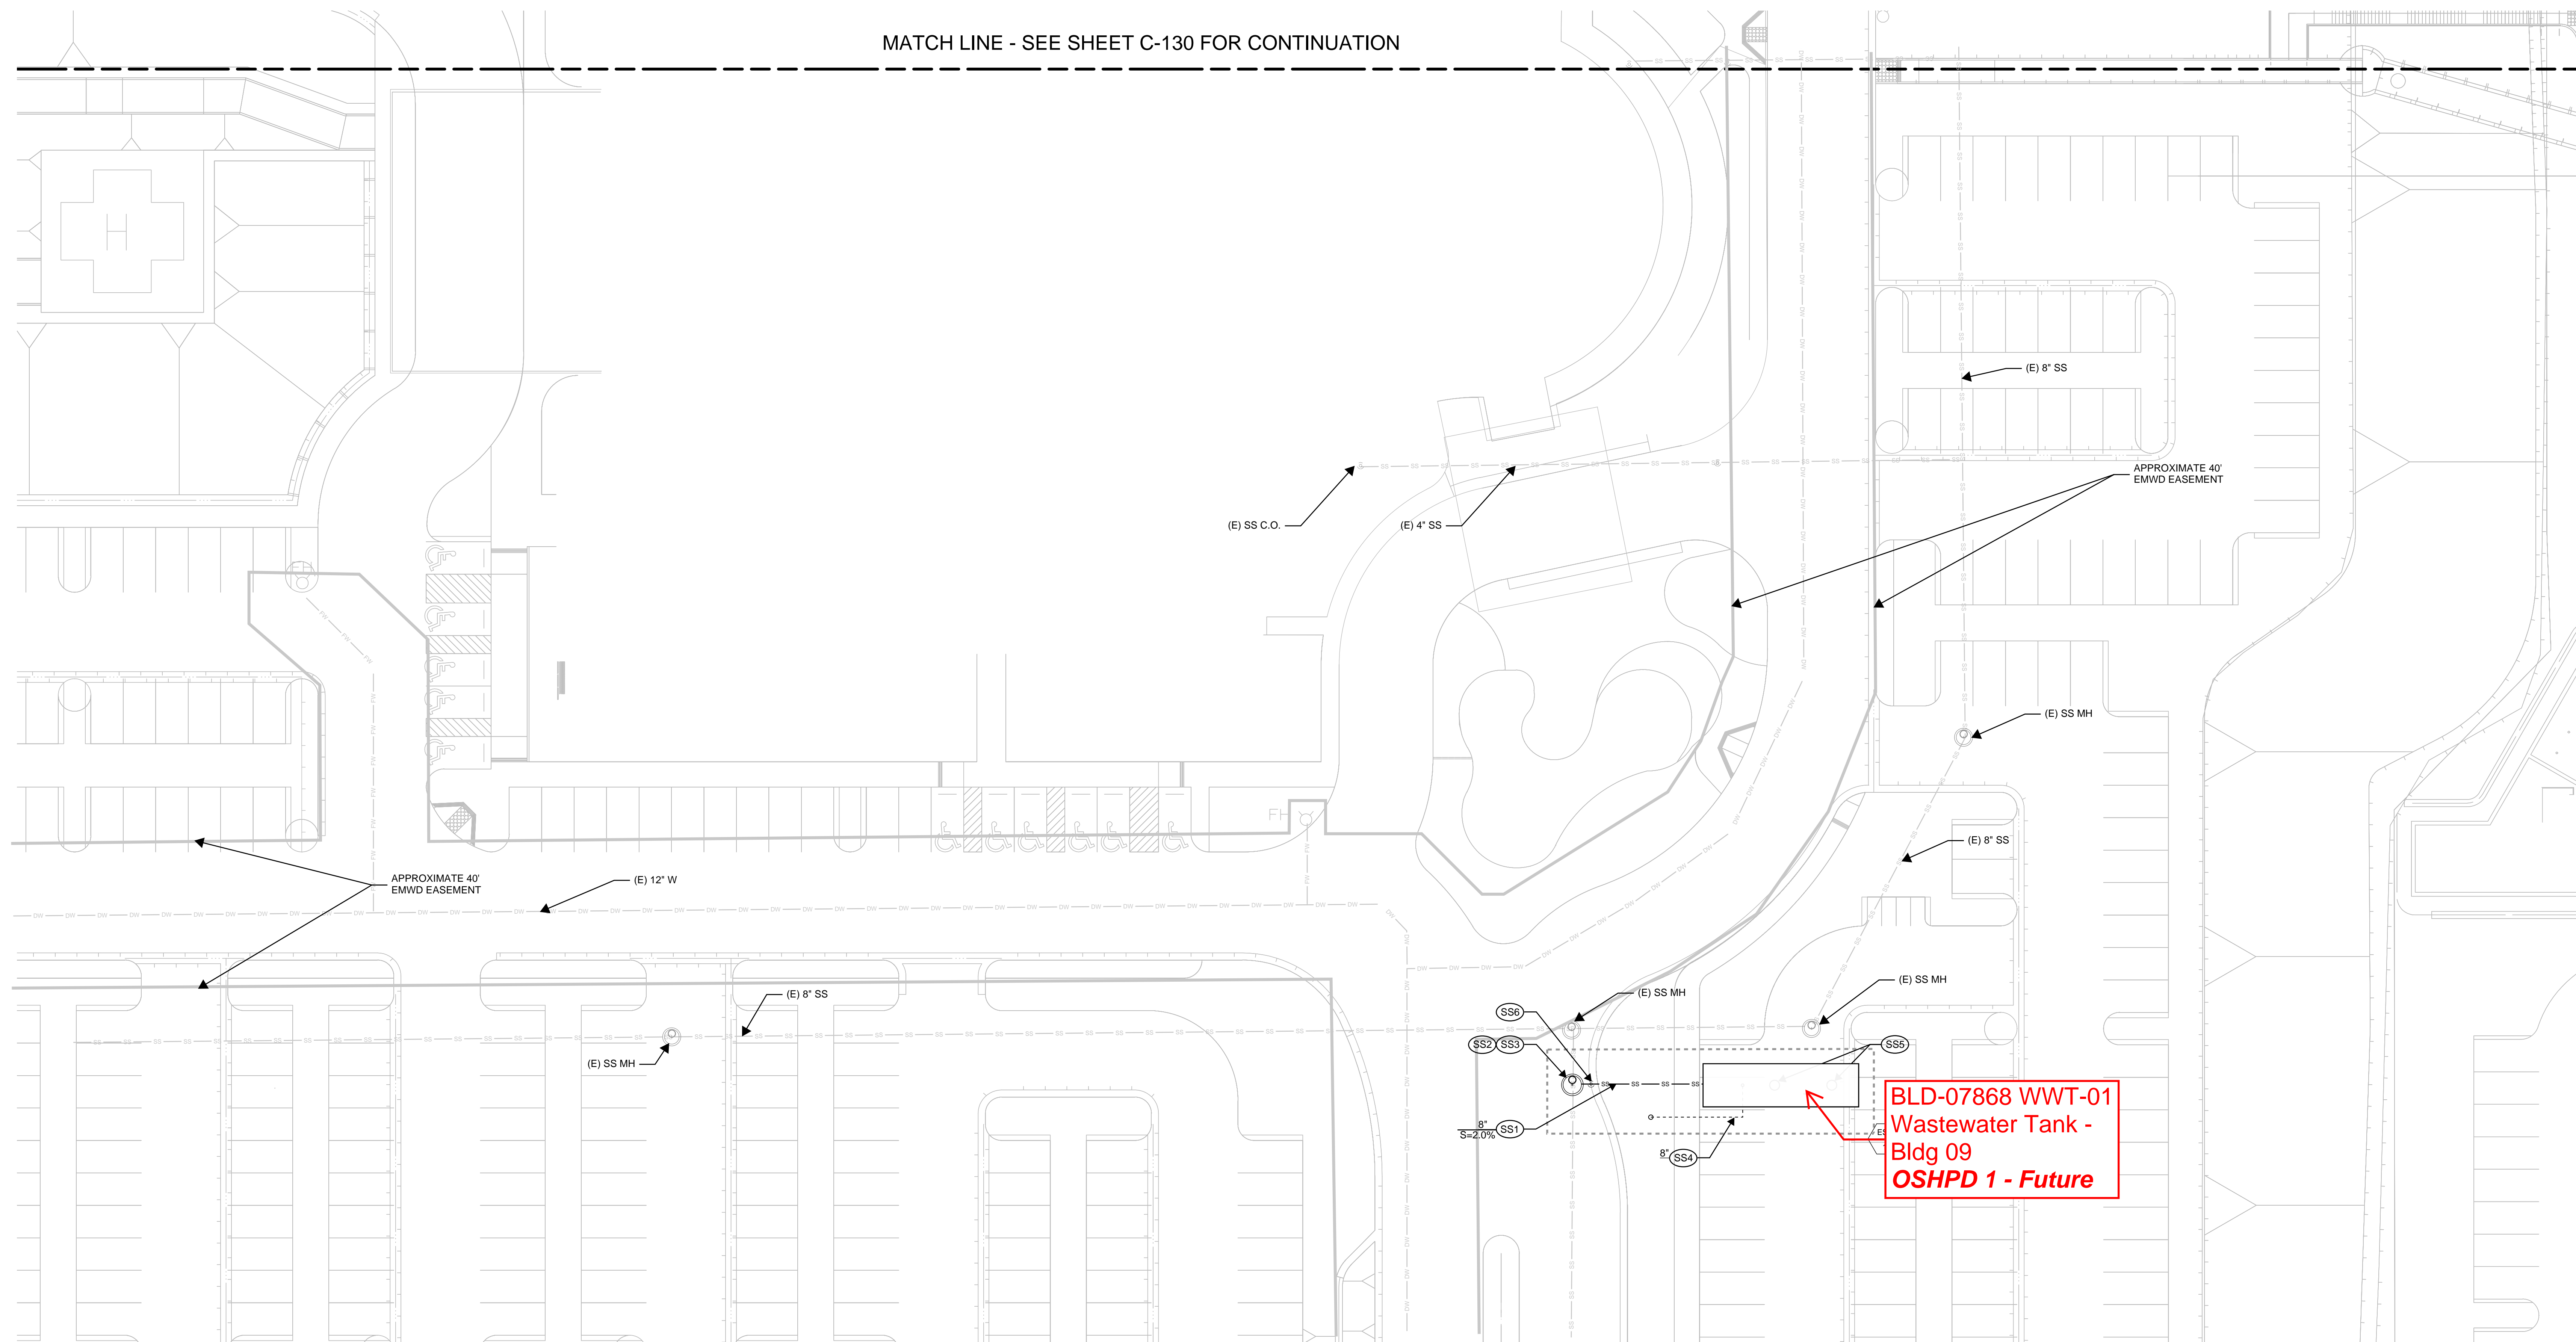

LEGEND:

	LIMIT LINE OF EROSION CONTROL
	PROPERTY LINE (FOR REFERENCE ONLY)
	SAWCUT
	SANITARY SEWER
	DOMESTIC WATER
	EXISTING CONTOURS
	SANITARY SEWER TANK, XERXES OR APPROVED EQUIVALENT. BACKFILL AND DEADMAN PER MANUFACTURER RECOMMENDATIONS. SEE PLUMBING SCHEDULE FOR DETAILS AND SPECIFICATIONS.
	DOMESTIC WATER TANK, XERXES OR APPROVED EQUIVALENT. BACKFILL AND DEADMAN PER MANUFACTURER RECOMMENDATIONS. SEE PLUMBING SCHEDULE FOR DETAILS AND SPECIFICATIONS.
	FUEL TANK, XERXES OR APPROVED EQUIVALENT. BACKFILL AND DEADMAN PER MANUFACTURER RECOMMENDATIONS. SEE PLUMBING SCHEDULE FOR DETAILS AND SPECIFICATIONS.
	PUMP HOUSE, SYNCROFLO OR APPROVED EQUIVALENT. SEE PLUMBING SCHEDULE FOR DETAILS AND SPECIFICATIONS.

UTILITY CONSTRUCTION NOTES:

SANITARY WATER

(SS1)	SANITARY SEWER PIPE PER DETAIL 1, SHEET C-500. SIZE AND SLOPE PER PLAN. PIPING MATERIAL PER PLUMBING PLAN.
(SS2)	POINT OF CONNECTION TO EXISTING SEWER.
(SS3)	60" PRECAST CONCRETE DIVERSION MANHOLE. REFER TO APWA STANDARD DETAIL 200-4 FOR ADDITIONAL DETAILS. REFER TO PLUMBING PLANS FOR DIVERSION VALVE ASSEMBLY DETAILS.
(SS4)	SEWER VENT. REFER TO PLUMBING SCHEDULE FOR DETAILS AND SPECIFICATIONS.
(SS5)	30" TRAFFIC TRATED MANWAY COVER FOR WATER TANK. REFER TO PLUMBING SCHEDULE FOR DETAILS AND SPECIFICATIONS.
(SS6)	CLEANOUT PER DETAIL 2, SHEET C-500.


NOTE:
SEE PLUMBING DRAWINGS FOR PIPING CONFIGURATION, VALVE DETAILS, AND SIZING INFORMATION.

NOTE:
PRIOR TO THE INSTALLATION OF ALL STORM DRAIN AND SEWER MAIN LINE CONNECTIONS, THE CONTRACTOR SHALL POT-HOLE AND VERIFY THE HORIZONTAL AND VERTICAL LOCATION OF THE MAIN LINE. IF CONDITIONS DIFFER FROM THOSE ON THE PLAN, THE CONTRACTOR SHALL NOTIFY THE ENGINEER AND SHALL NOT BEGIN CONSTRUCTION UNTIL THE CHANGED CONDITION HAS BEEN EVALUATED.

BLD-07868 WWT-01
Wastewater Tank -
Bldg 09
OSHPD 1 - Future

LEGEND:

	OSHPD 1
	Seismic Separation

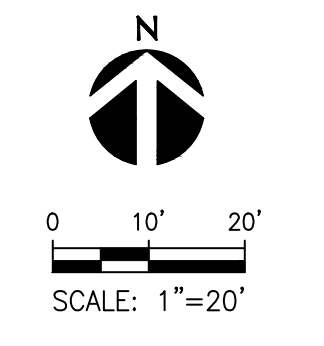

MASCARI DINH
architects
1350 COLUMBIA ST., SUITE 900
SAN DIEGO, CA 92101
619.814.0080 FAX 619.814.0081

kpff
700 South Flower Street
Suite 2100
Los Angeles, CA 90017
310.213.4181 ext. 2001
www.kpff.com

HCAI # S260391-33-00

KEY PLAN

LOMA LINDA UNIVERSITY
MEDICAL CENTER - MURRIETA

28062 BAXTER ROAD,
MURRIETA, CA 92583

LOMA LINDA UNIVERSITY
MEDICAL CENTER
MURRIETA
NPC-5 RETROFIT

TITLE	UTILITY PLAN
PROJECT NO.	2023014.20
DRAWN: SG	CHECK: BK
ISSUE:	DATE:
HCAI SUBMITTAL	FEBRUARY 25, 2026

P:\2025\5500476 Loma Linda University Murrieta NPC5 CA\0\Shere\2500476-C1\1\UT.dwg, Feb 23, 2026 - 4:57pm