


Bayshire San Dimas Post-Acute
Facility No. 27267 7/16/2025

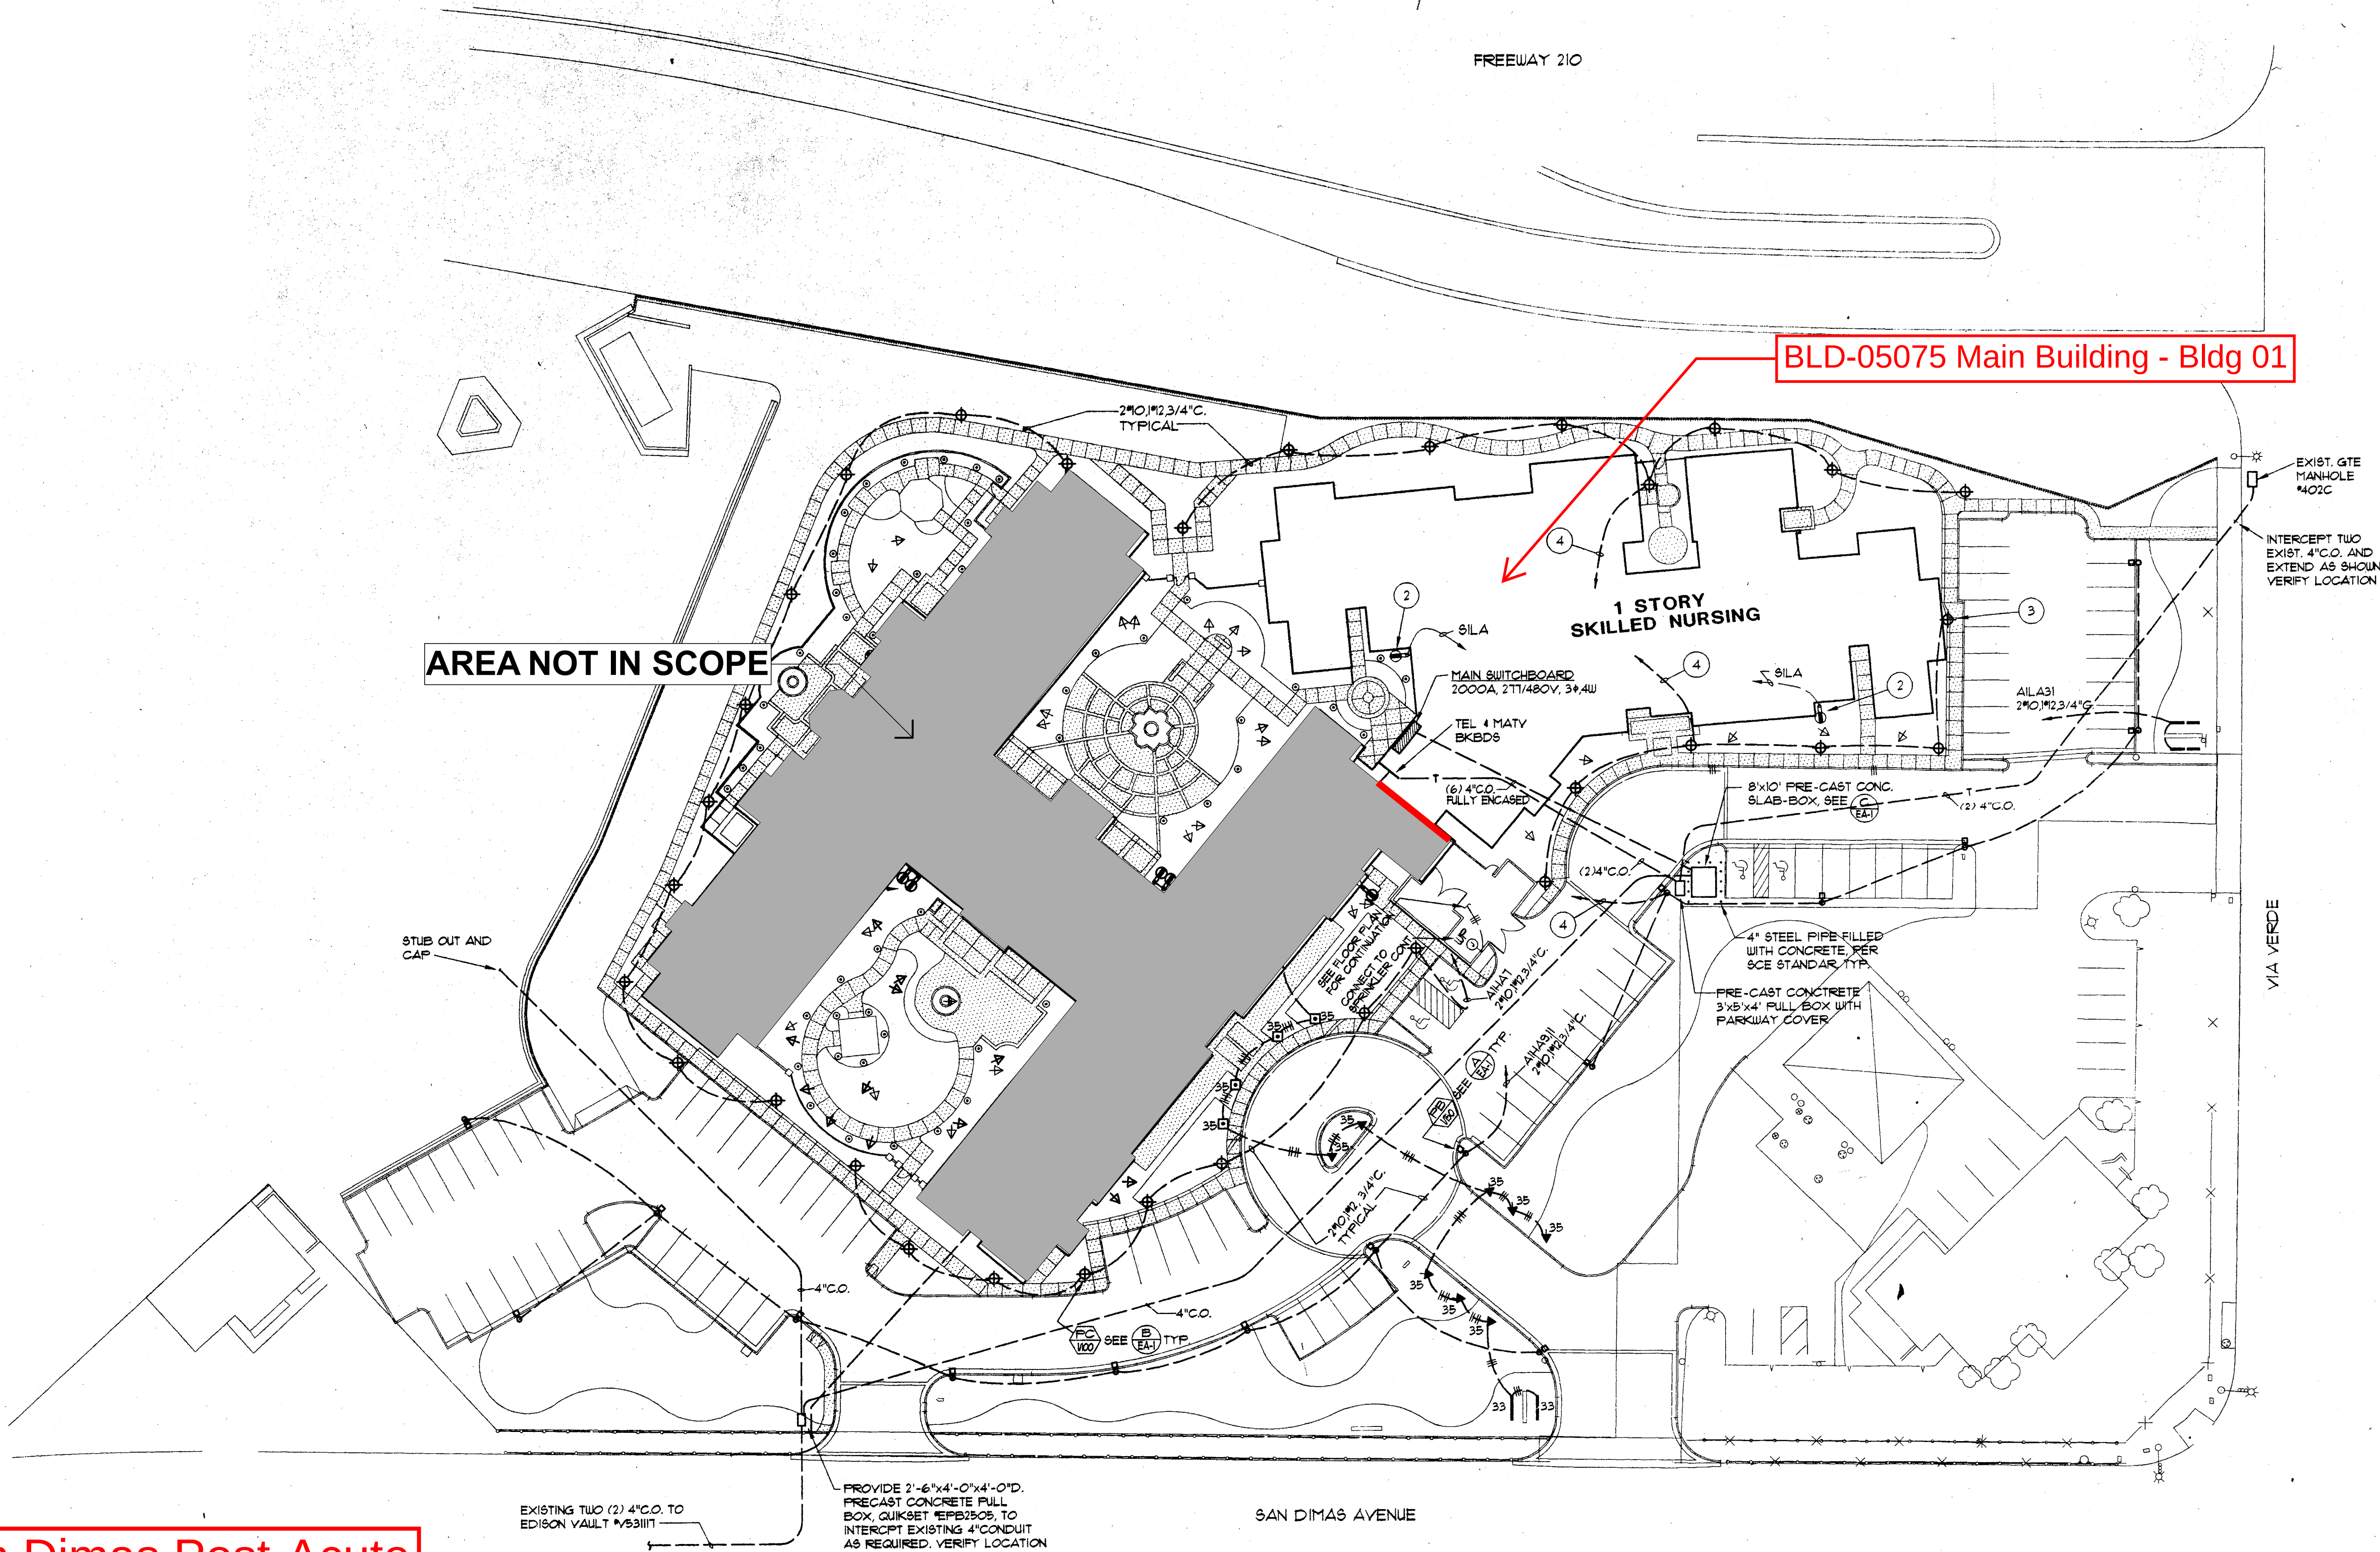

ELECTRICAL SITE PLAN
SCALE: 1" = 30'-0"

